



All ideas, designs, arrangement and plans indicated or represented by this drawing are the property of Panda Express Inc. and were created for use on this specific project. None of these ideas, designs, arrangements or plans may be used by or disclosed to any person, firm, or corporation without the written permission of Panda Express Inc.

REVISIONS

[illegible]

ISSUE DATE:

	PERMIT / BID SET	01-24-



DRAWN BY: G. COLLINS

PANDA PROJECT #: D8159
ARCH PROJECT #: JCDT21-0070





ELECTRICAL DETAILS, DIAGRAMS

TRUE WARM & WELCOME 2500 R2

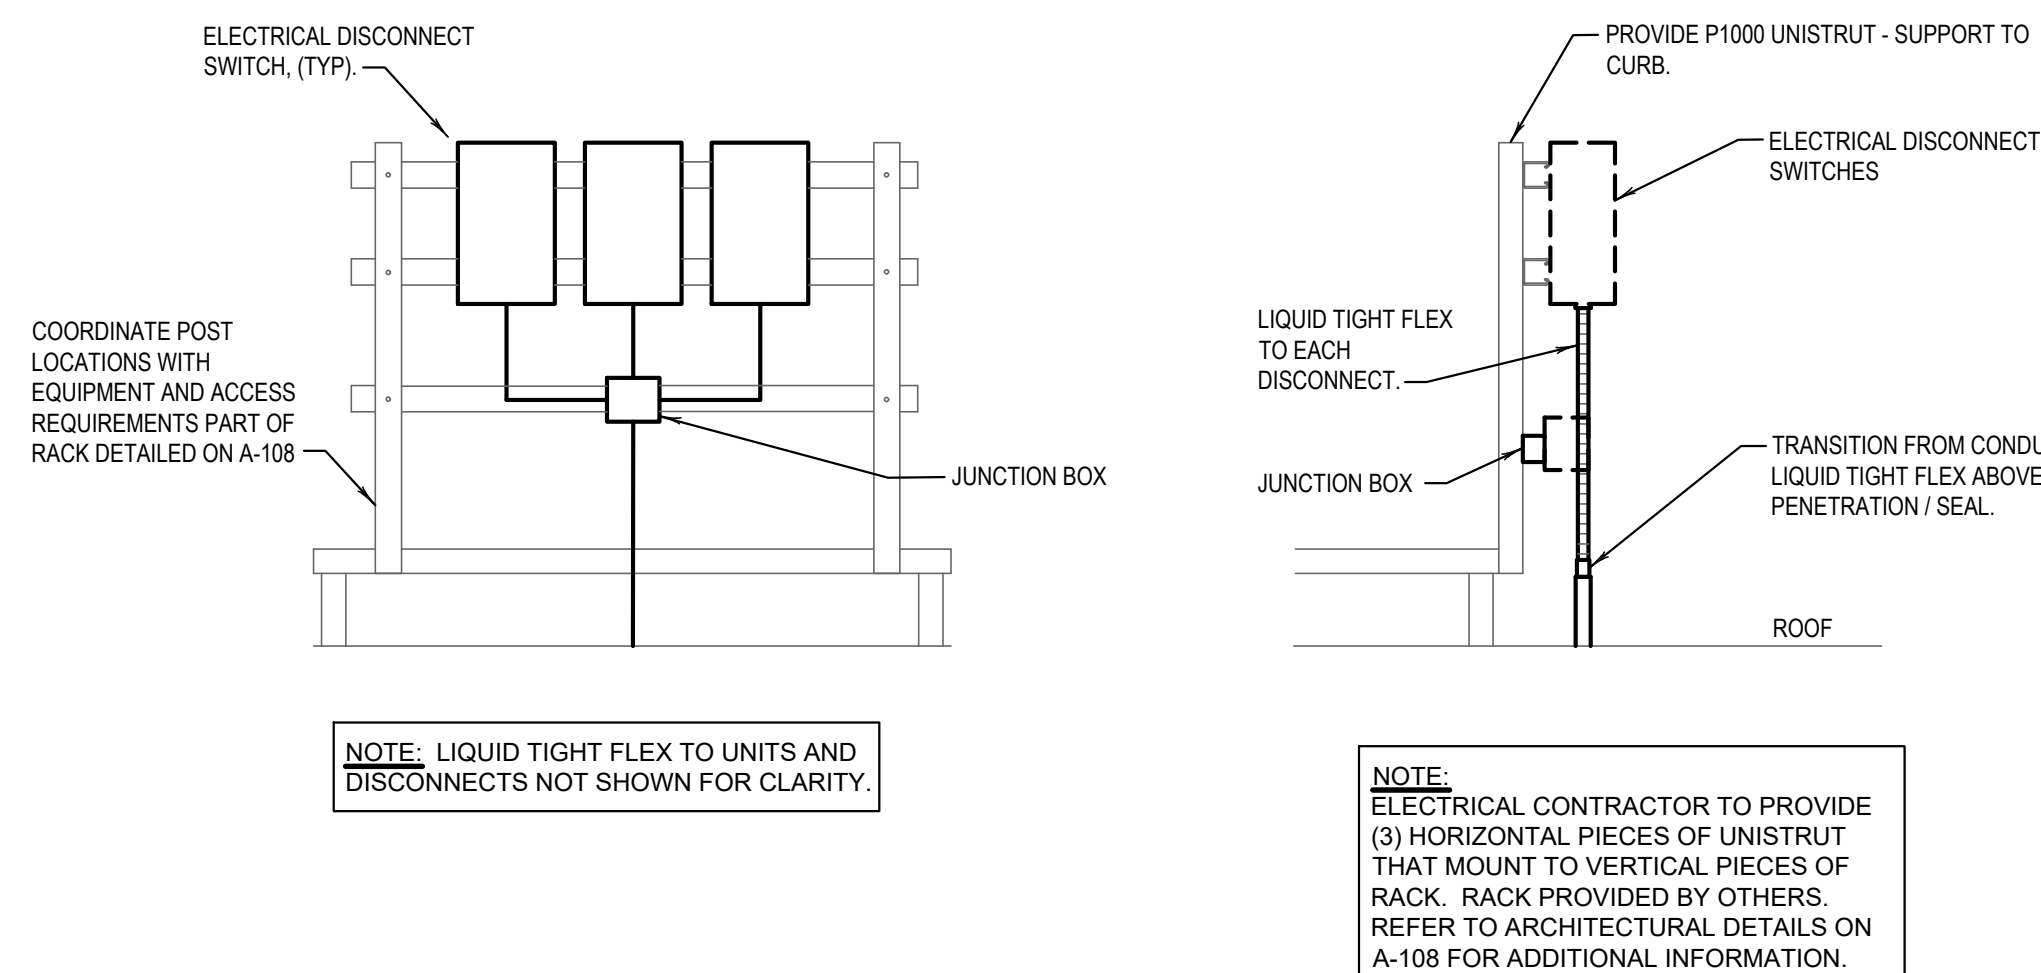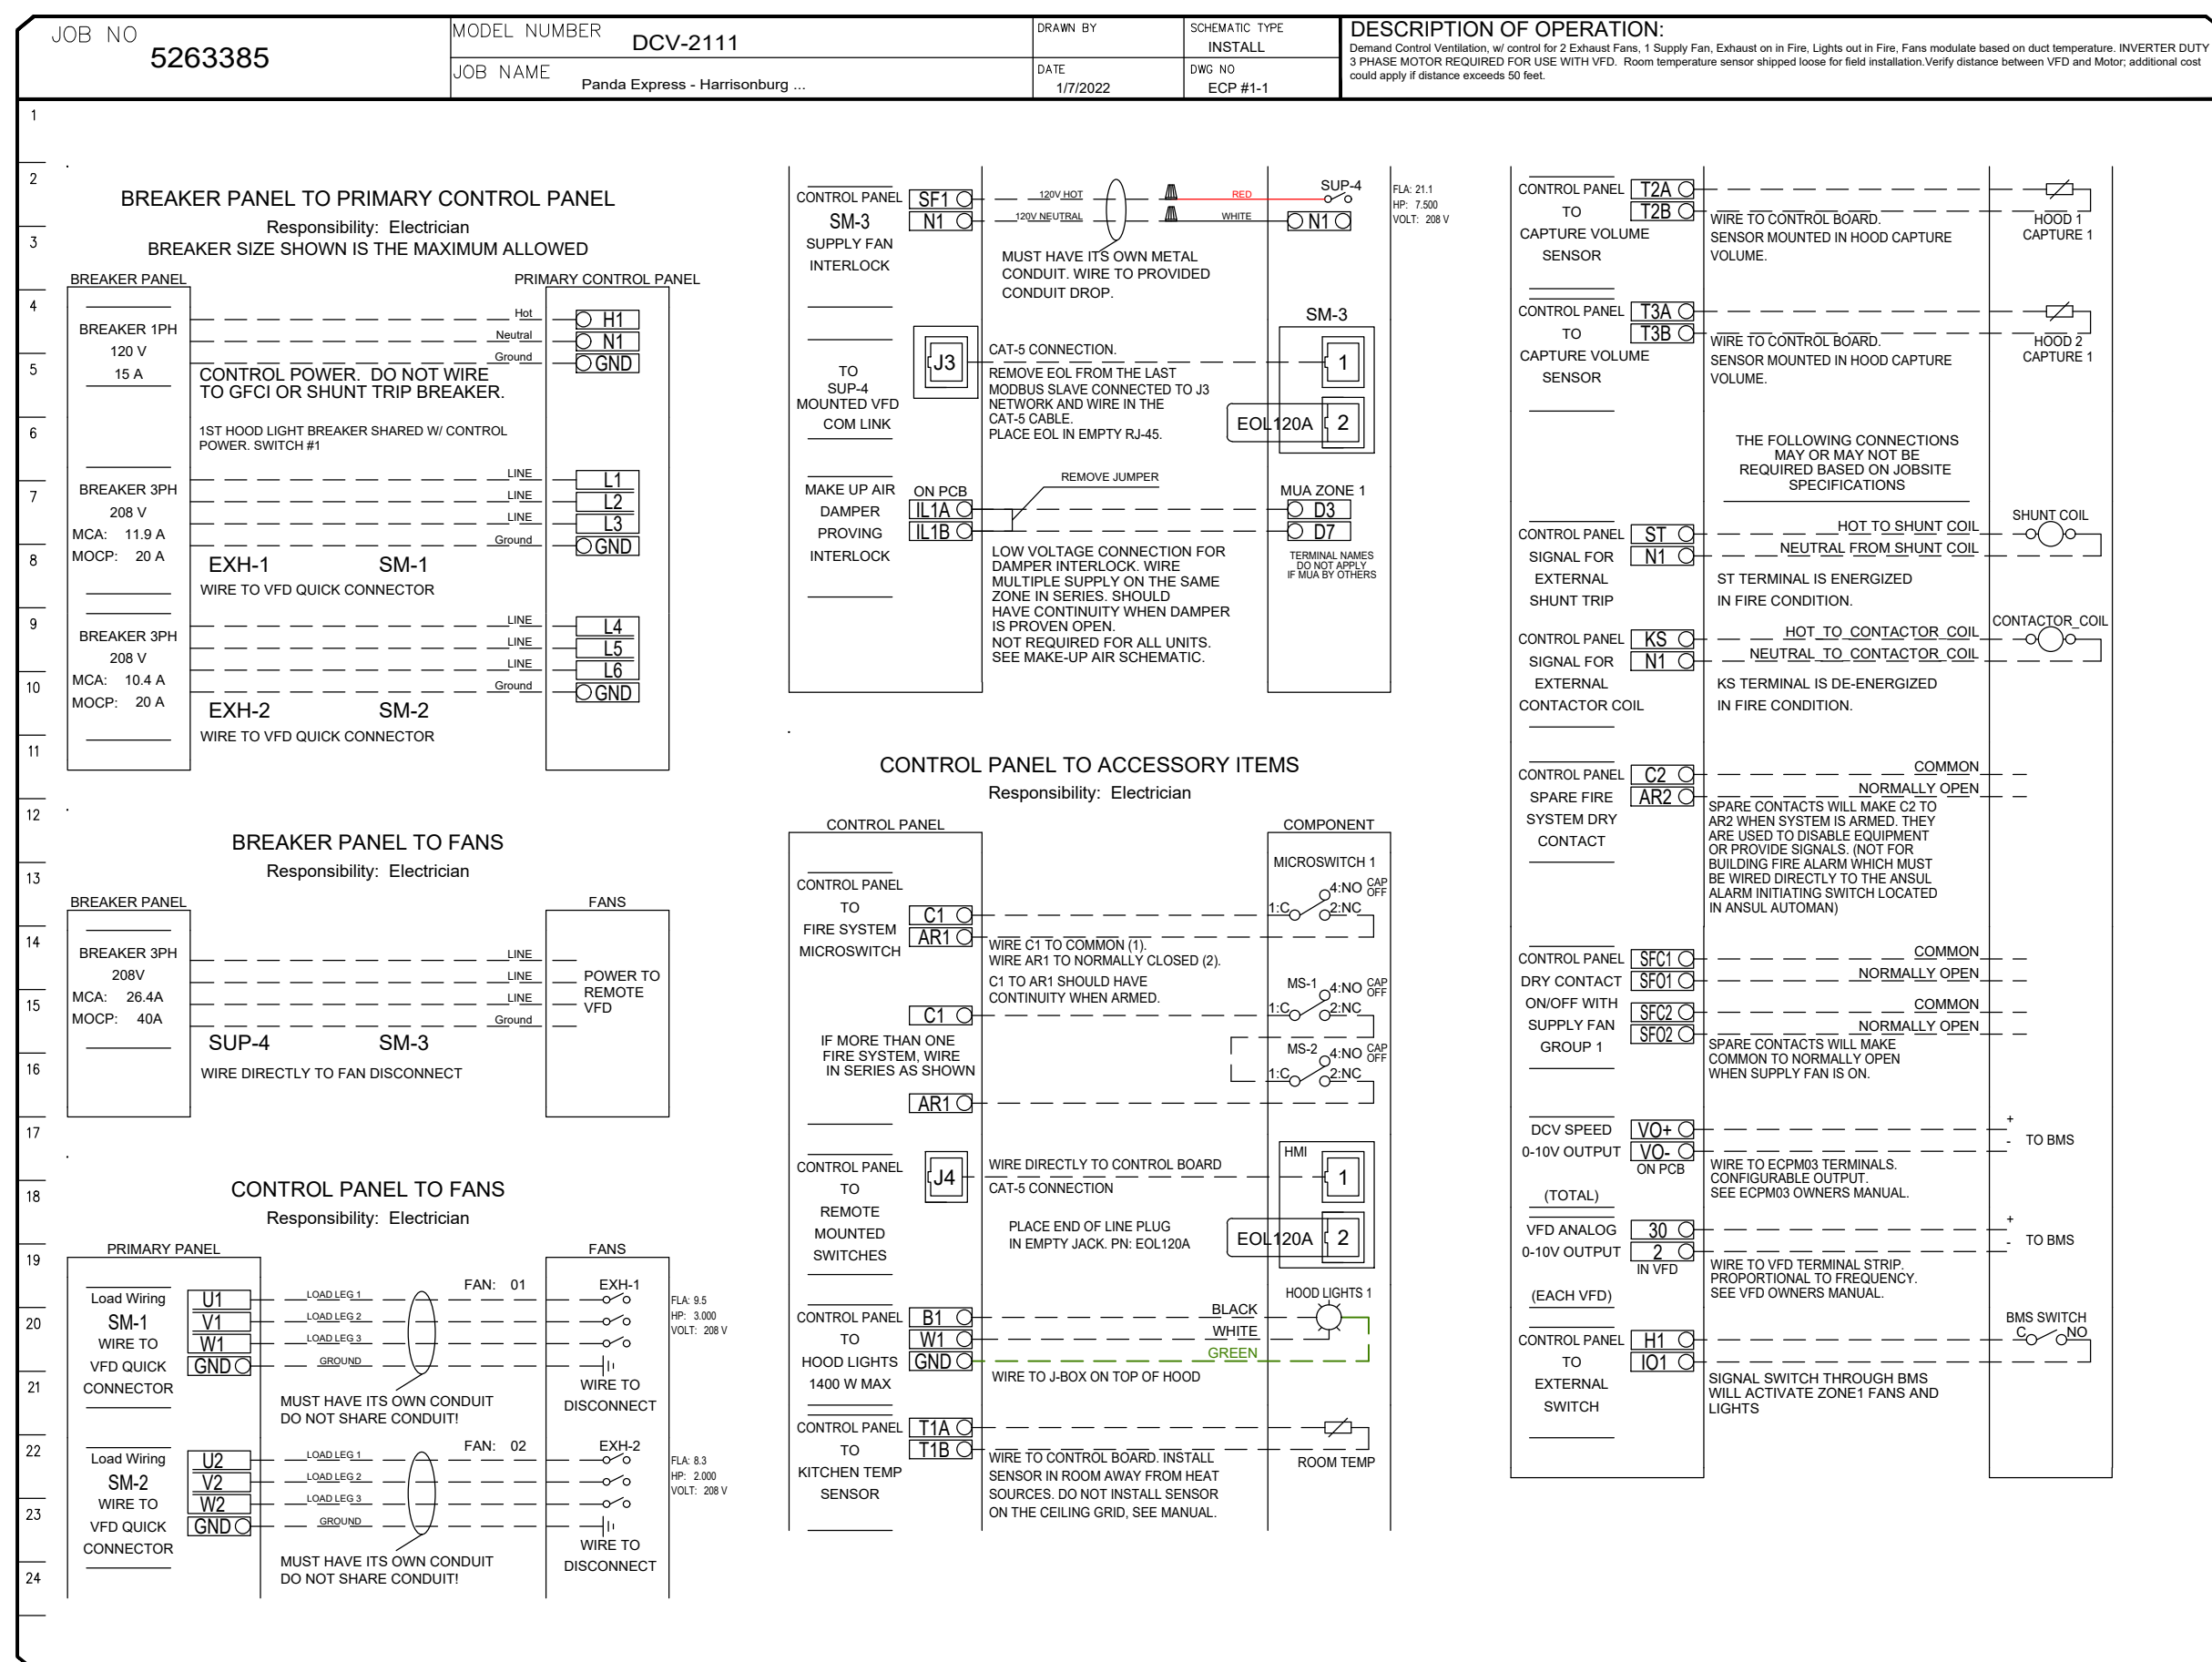

EQUIPMENT DISCONNECT SWITCH SUPPORT	2
-------------------------------------	---

NOT TO SCALE F-40

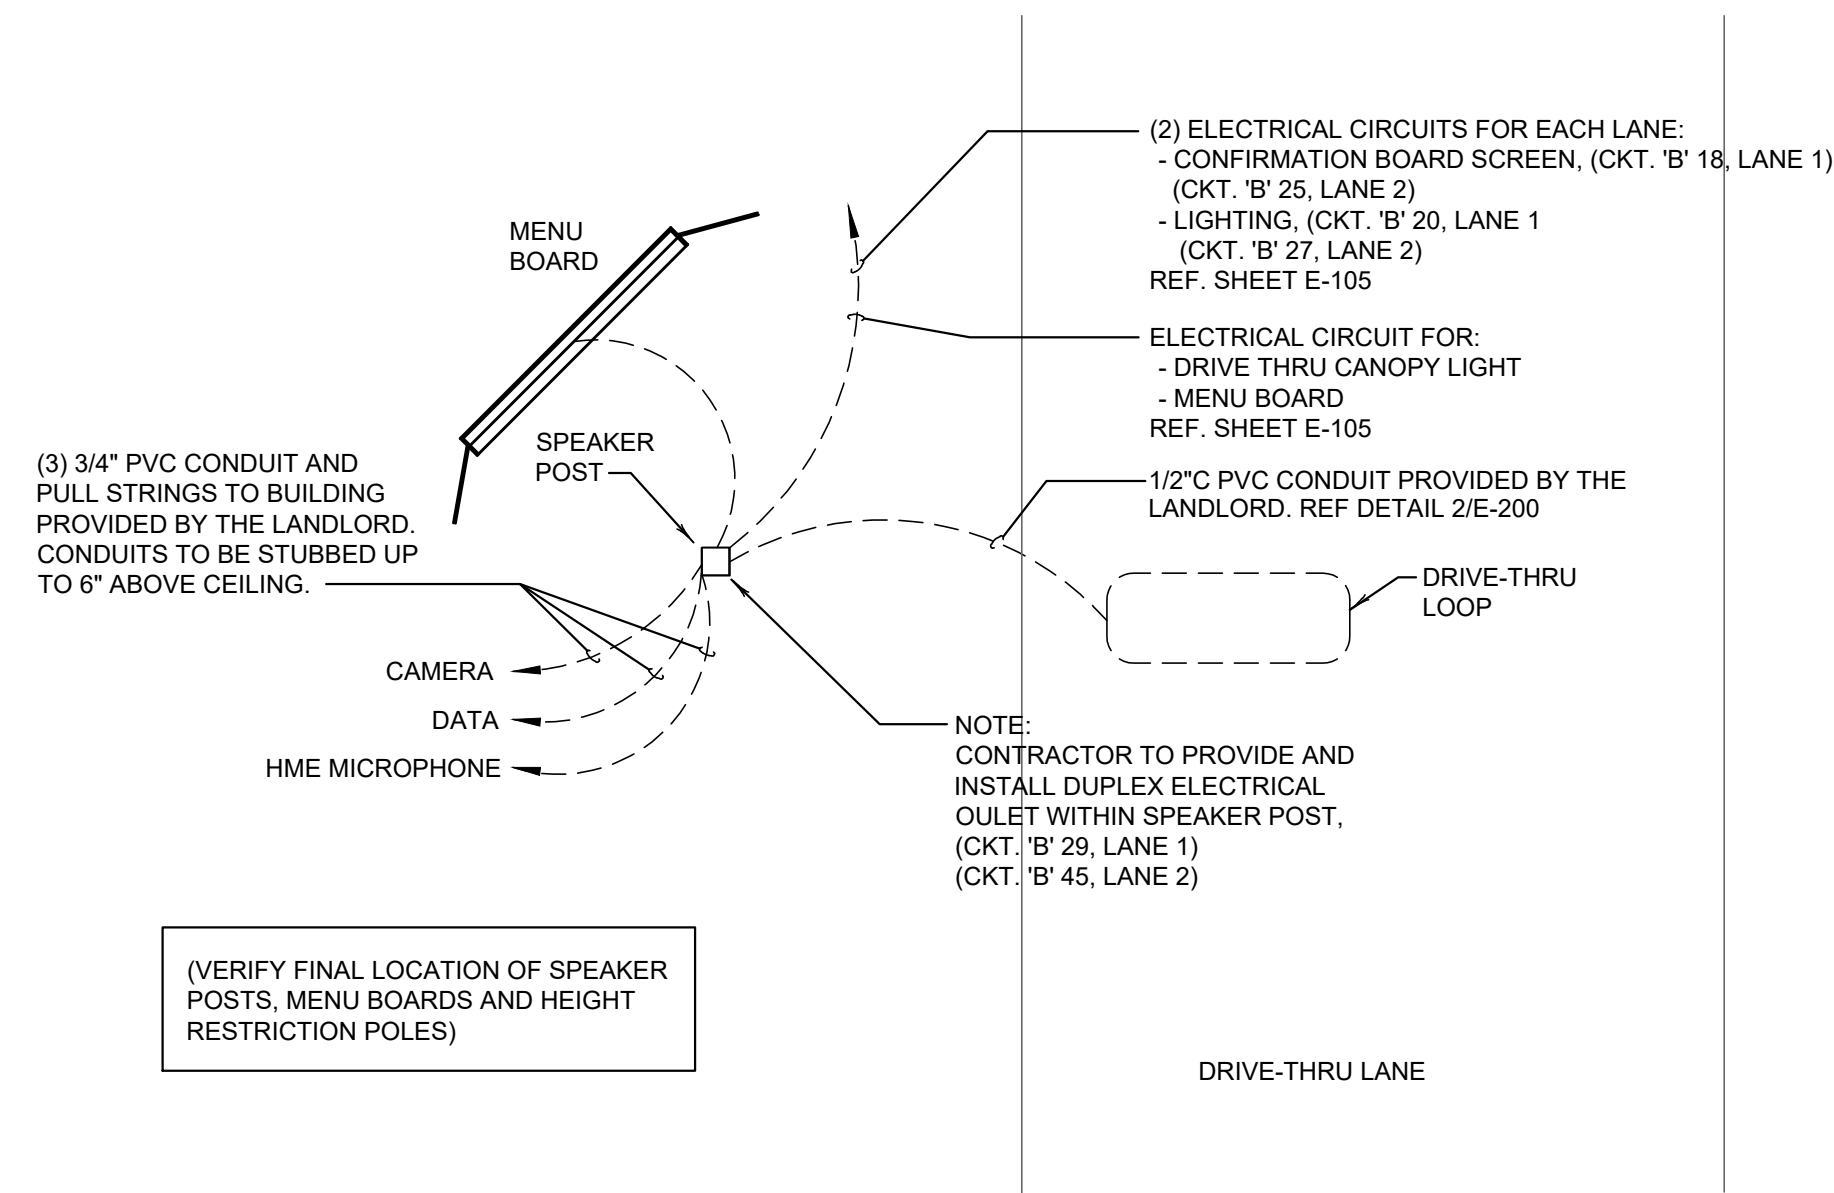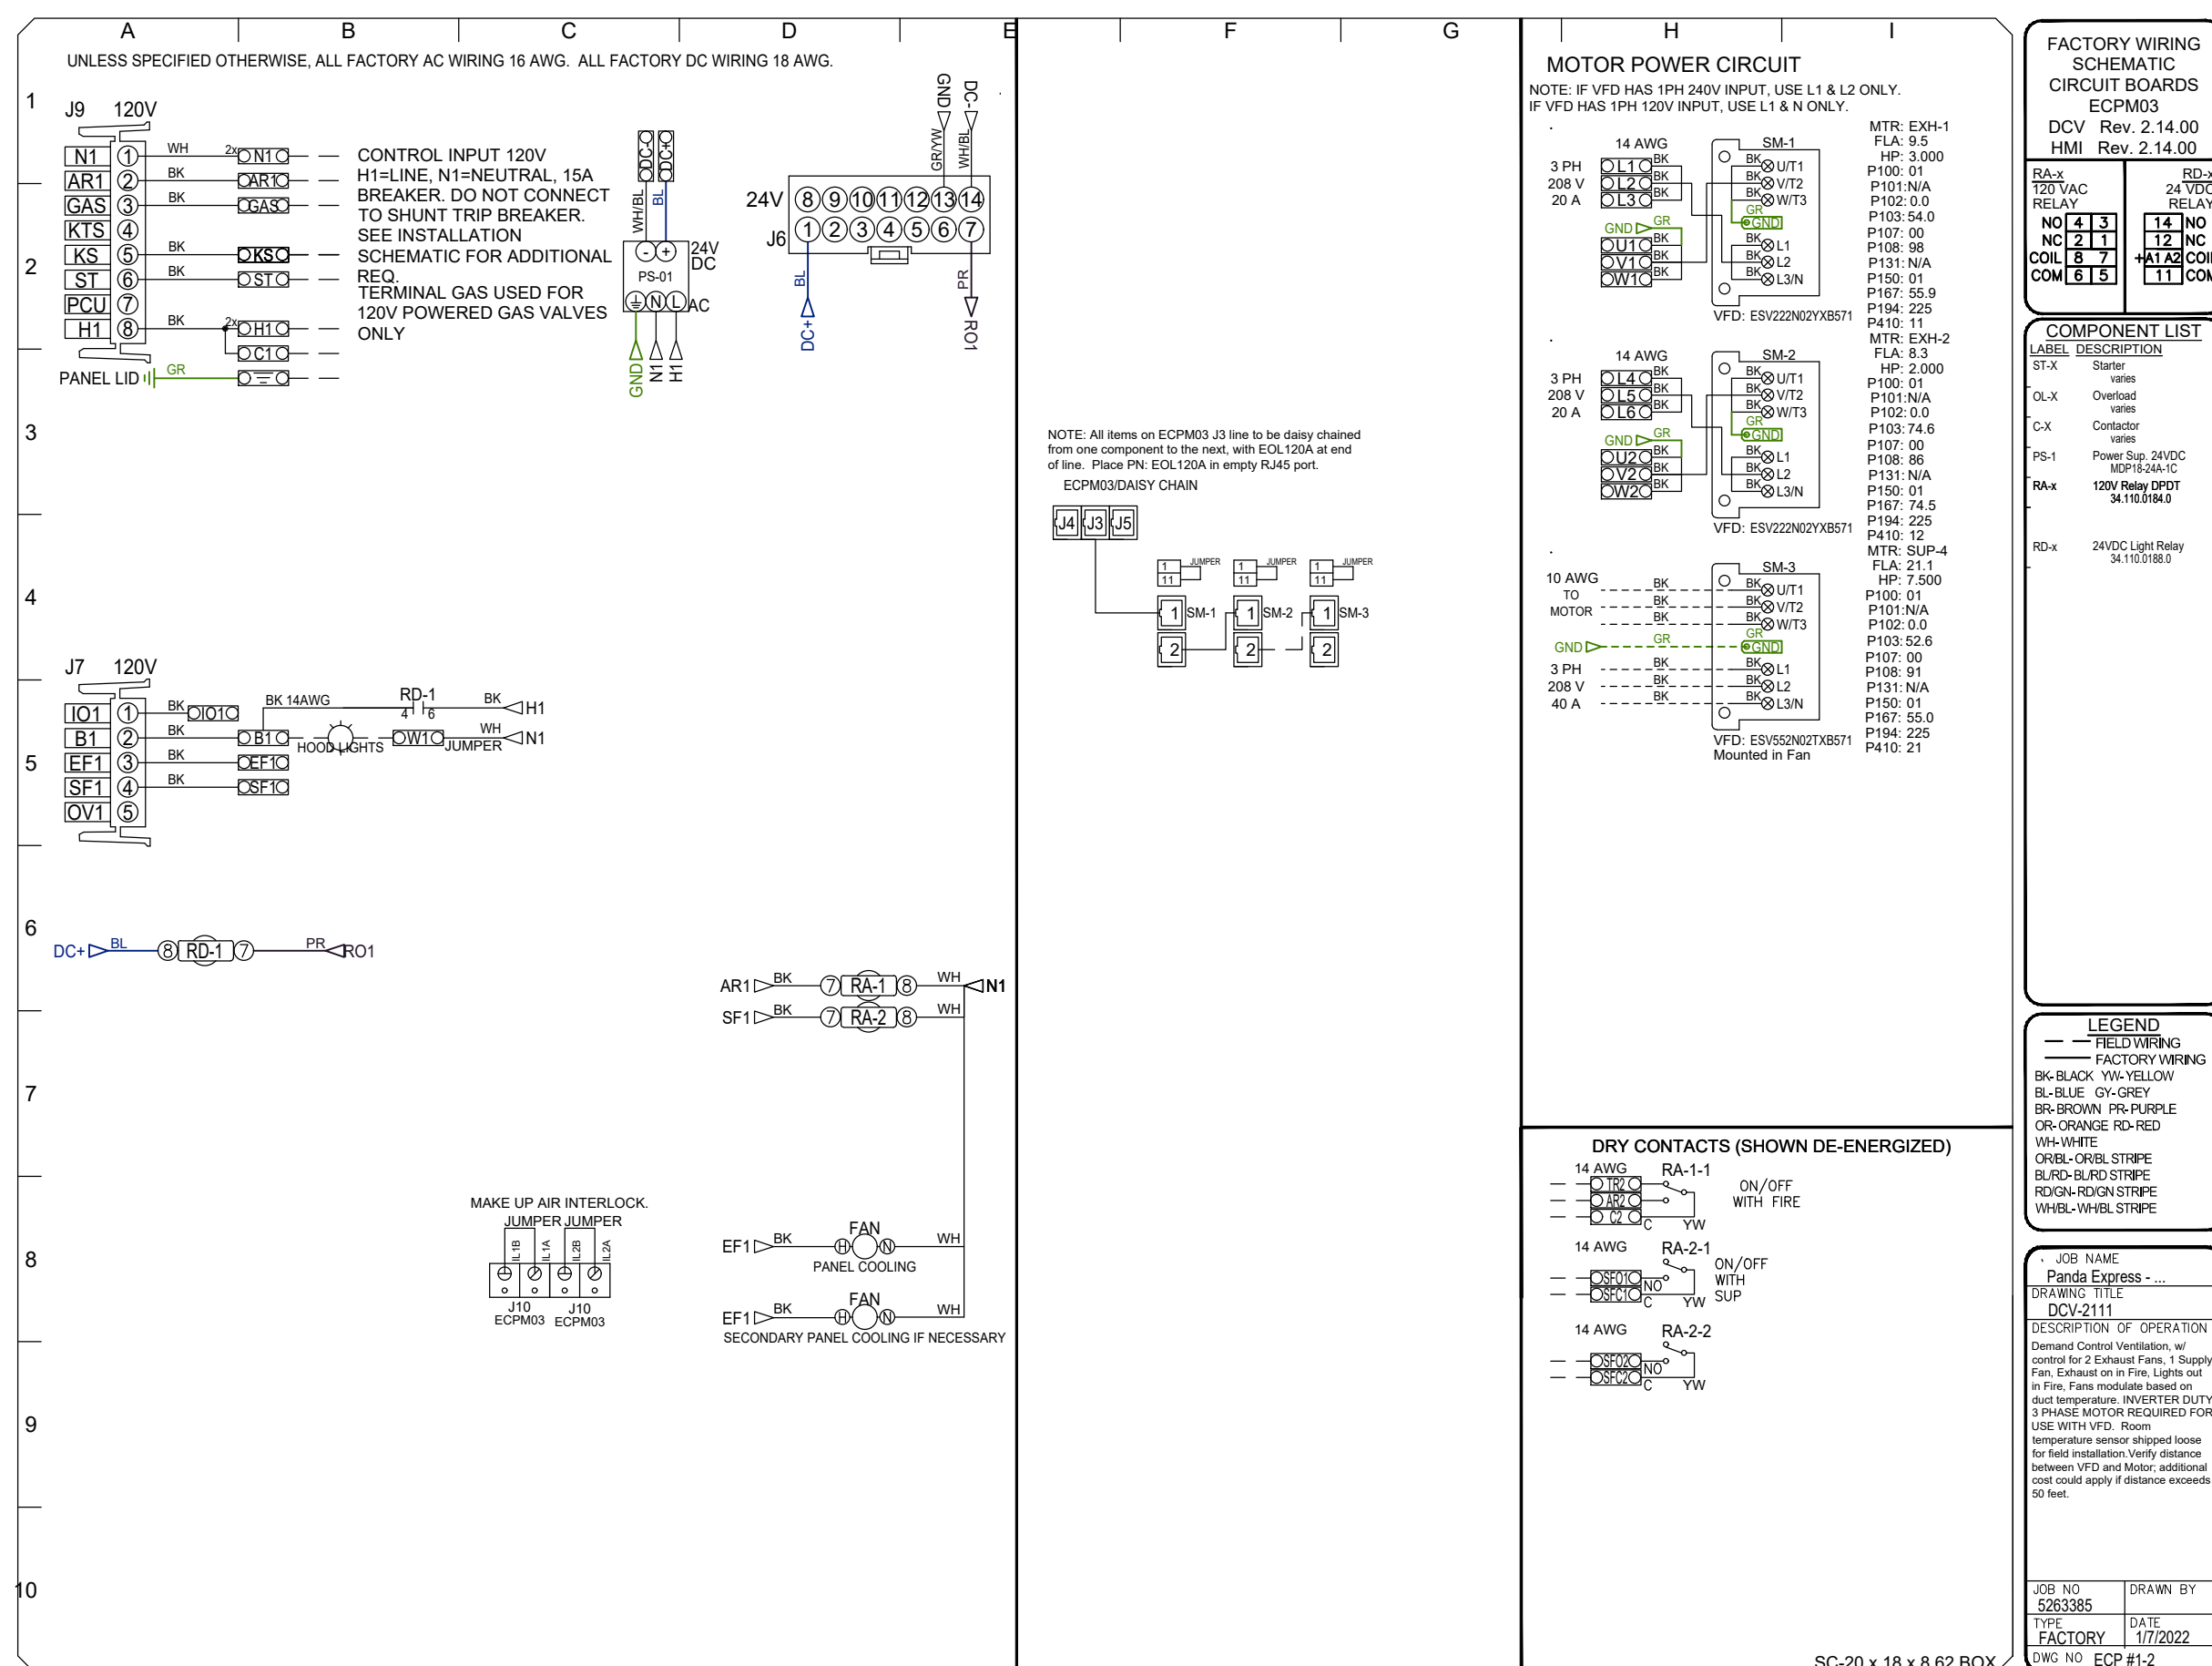

KITCHEN EXHAUST SYSTEM DIAGRAM	3
--------------------------------	---

NOT TO SCALE F-401

MENU BOARD & SENSOR LOOP - TYPICAL FOR EACH LANE	1
--	---

NOT TO SCALE F-40

TRUE WARM & WELCOME 2500 R2